


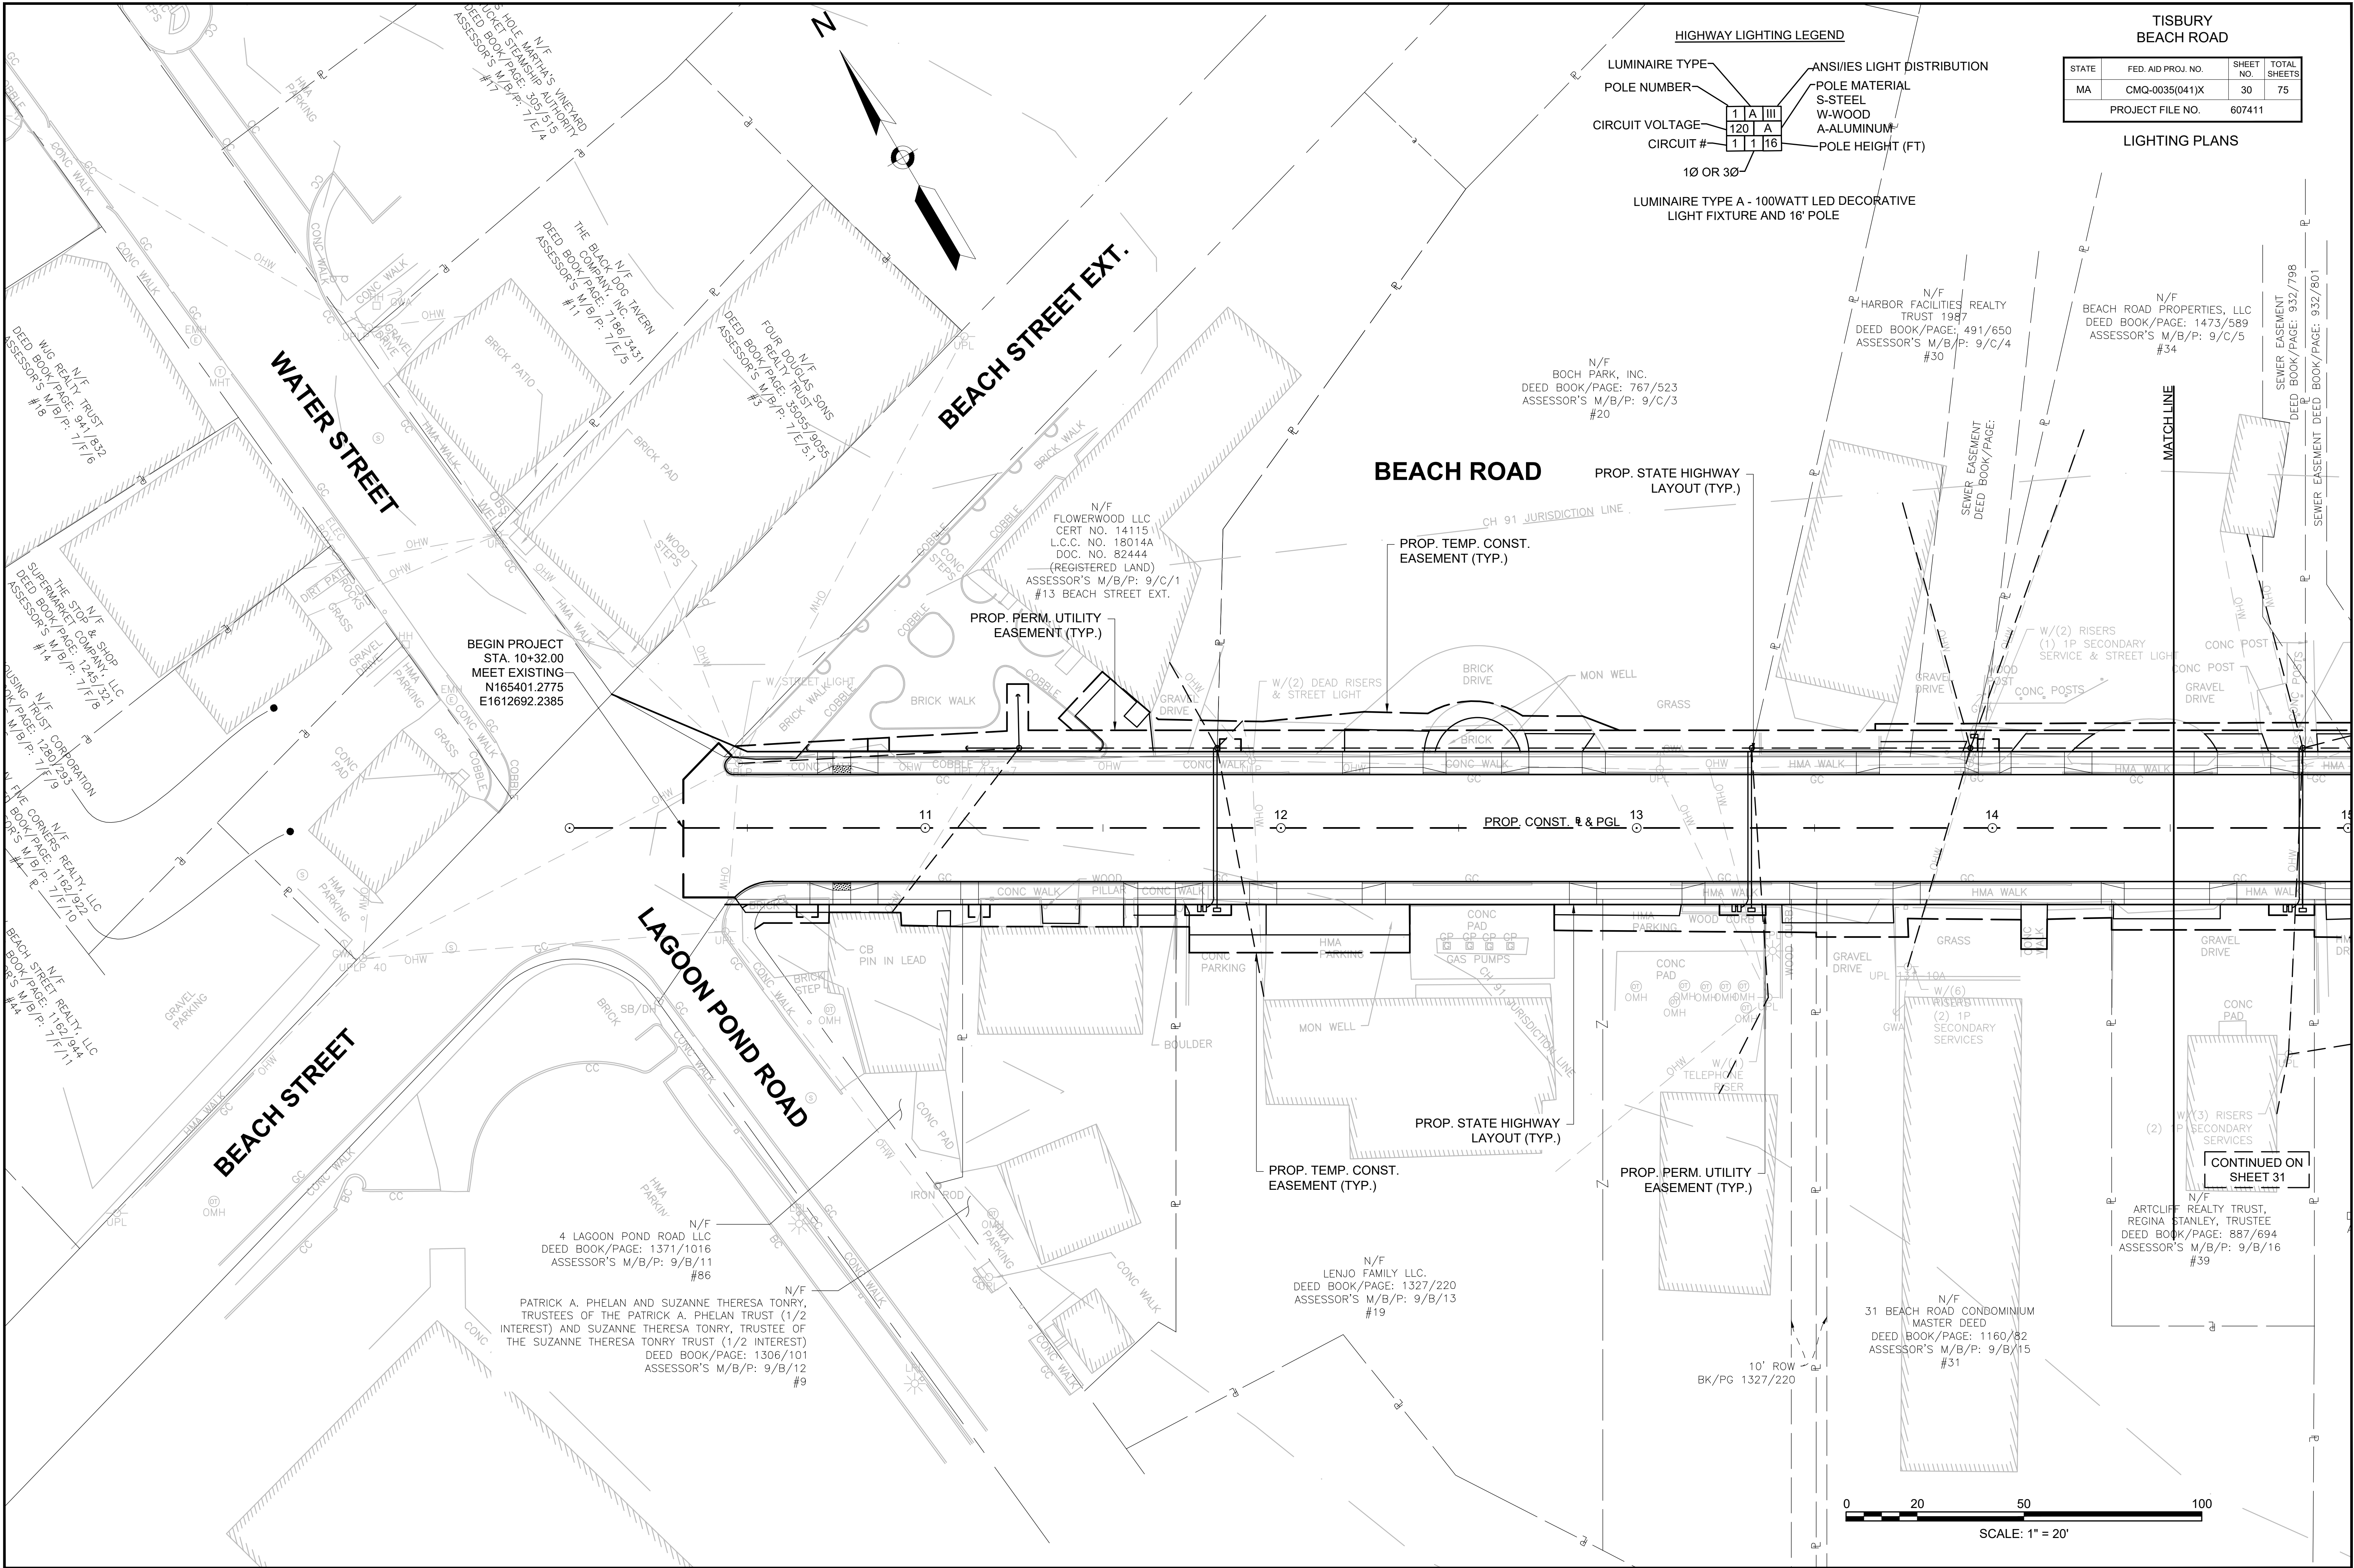

HIGHWAY LIGHTING LEGEND

LUMINAIRE TYPE	ANSI/IES LIGHT DISTRIBUTION
POLE NUMBER	POLE MATERIAL
CIRCUIT VOLTAGE	W-WOOD
CIRCUIT #	A-ALUMINUM
	POLE HEIGHT (FT)

10 OR 30

LUMINAIRE TYPE A - 100WATT LED DECORATIVE LIGHT FIXTURE AND 16' POLE

TISBURY BEACH ROAD

STATE	FED. AID PROJ. NO.	SHEET NO.	TOTAL SHEETS
MA	CMQ-0035(041)X	30	75

PROJECT FILE NO. 607411

LIGHTING PLANS

BEGIN PROJECT STA. 10+32.00
MEET EXISTING
N165401.2775
E1612692.2385

4 LAGOON POND ROAD LLC
DEED BOOK/PAGE: 1371/1016
ASSESSOR'S M/B/P: 9/B/11 #86


PATRICK A. PHELAN AND SUZANNE THERESA TONRY, TRUSTEES OF THE PATRICK A. PHELAN TRUST (1/2 INTEREST) AND SUZANNE THERESA TONRY, TRUSTEE OF THE SUZANNE THERESA TONRY TRUST (1/2 INTEREST)
DEED BOOK/PAGE: 1306/101
ASSESSOR'S M/B/P: 9/B/12 #9

N/F
LENUO FAMILY LLC.
DEED BOOK/PAGE: 1327/220
ASSESSOR'S M/B/P: 9/B/13 #19

N/F
31 BEACH ROAD CONDOMINIUM MASTER DEED
DEED BOOK/PAGE: 1160/82
ASSESSOR'S M/B/P: 9/B/15 #31

N/F
ARTCLIFF REALTY TRUST, REGINA STANLEY, TRUSTEE
DEED BOOK/PAGE: 887/694
ASSESSOR'S M/B/P: 9/B/16 #39

CONTINUED ON SHEET 31

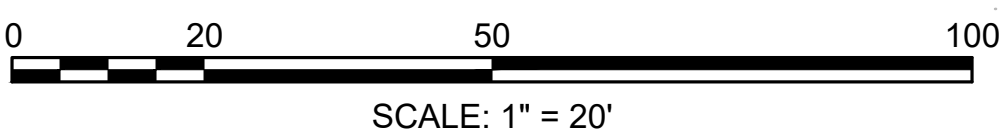


TISBURY
BEACH ROAD

STATE	FED. AID PROJ. NO.	SHEET NO.	TOTAL SHEETS
MA	CMQ-0035(041)X	31	75
PROJECT FILE NO.		607411	

LIGHTING PLANS


CONTINUED ON
SHEET 32

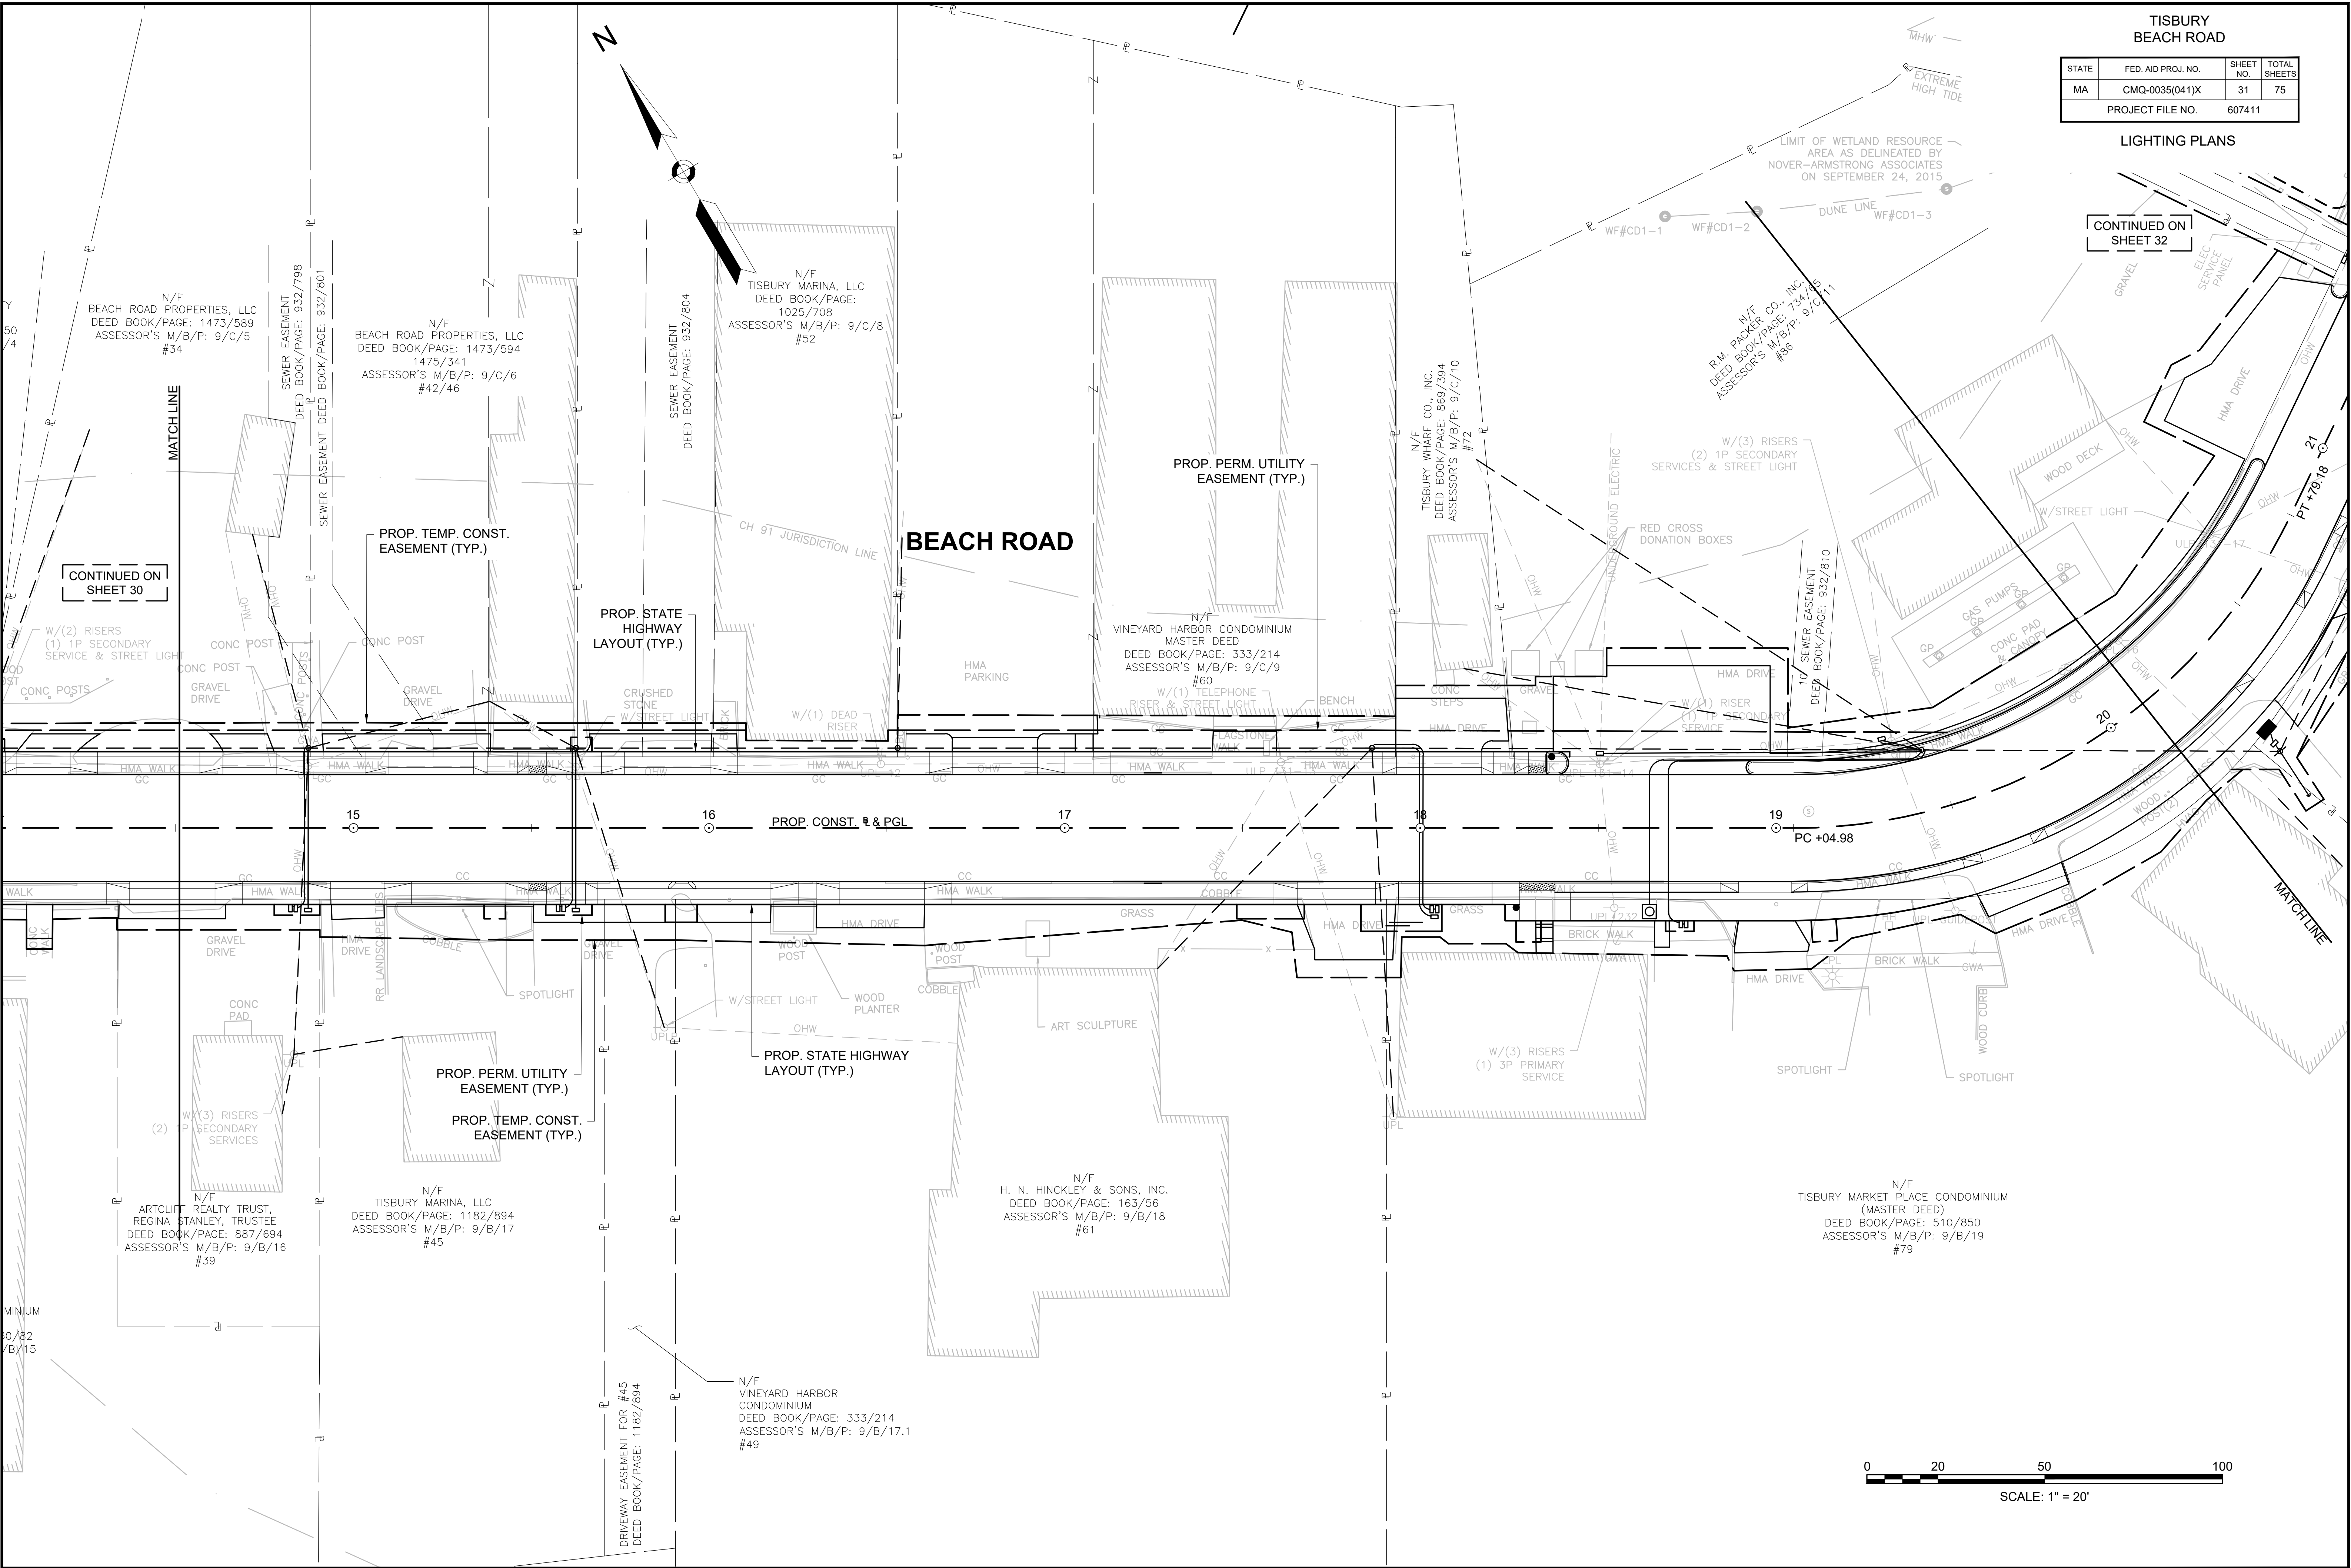

CONTINUED ON
SHEET 33



 
607411 HD (SI) DWG Plotted on 22-Jul-2020 10:51 AM



TISBURY
BEACH ROAD

STATE	FED. AID PROJ. NO.	SHEET NO.	TOTAL SHEETS
MA	CMQ-0035(041)X	34	75
PROJECT FILE NO.		607411	

LIGHTING PLANS

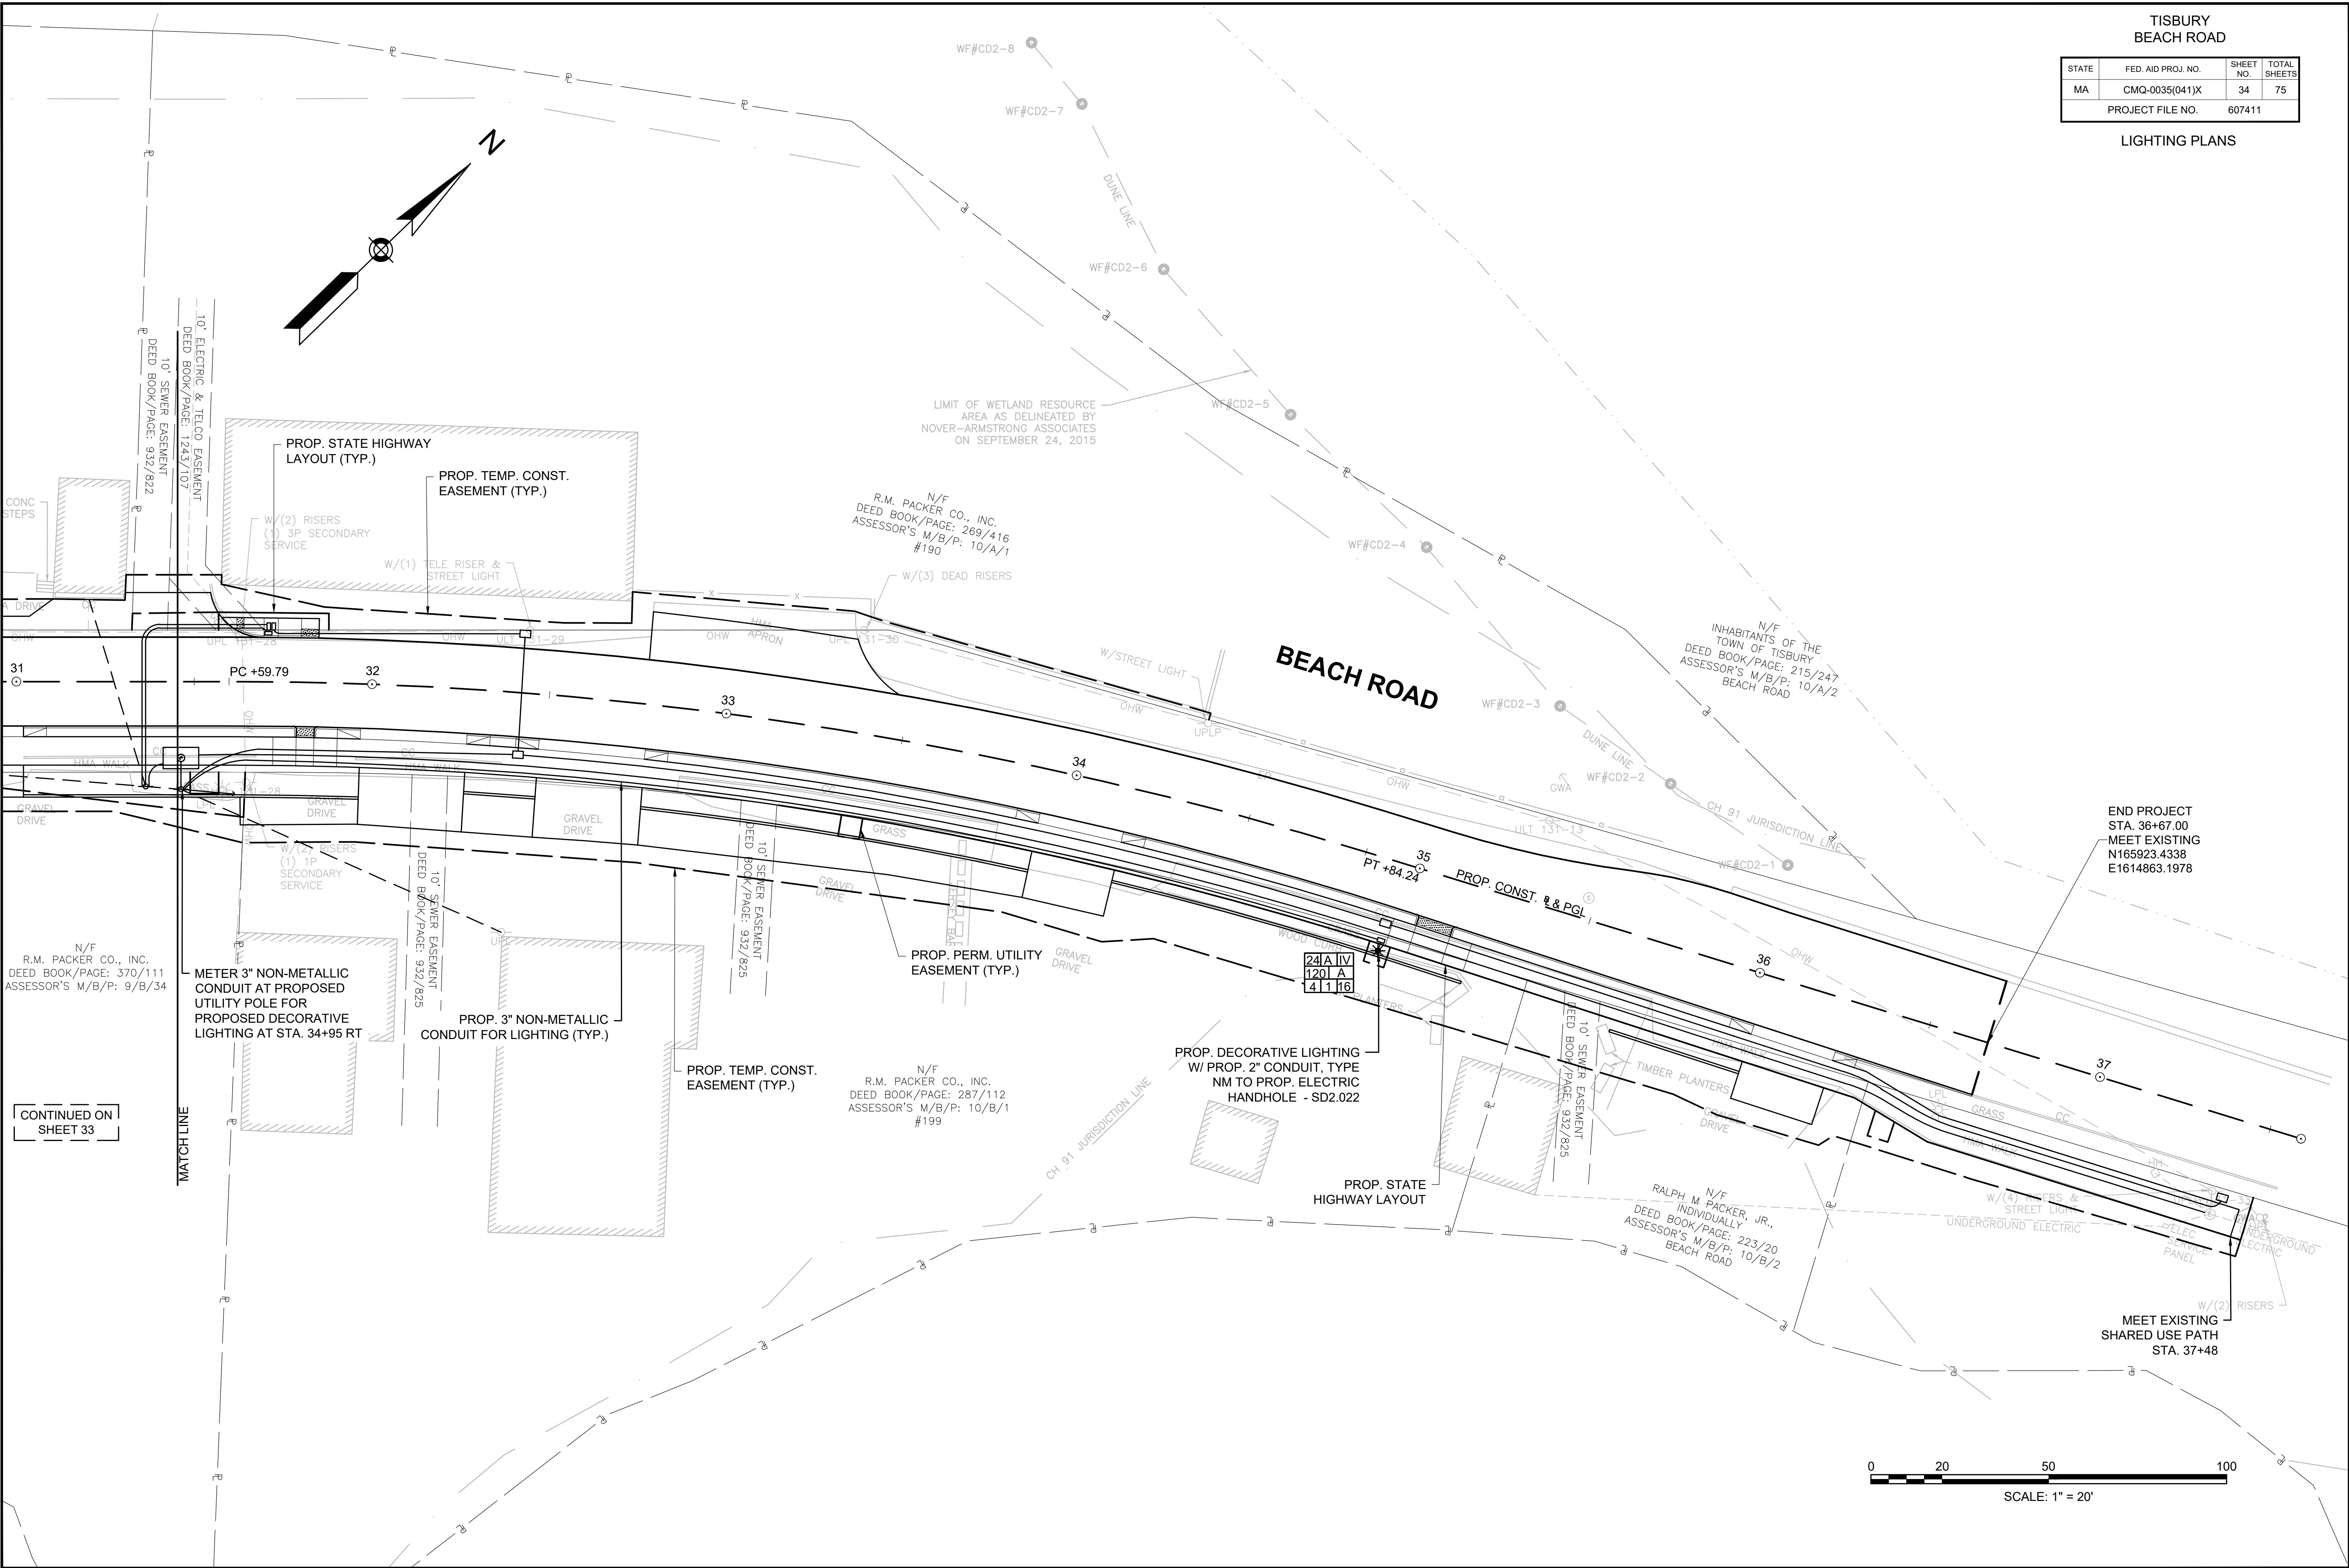

CONTINUED ON
SHEET 33